


1

2

3

4

5

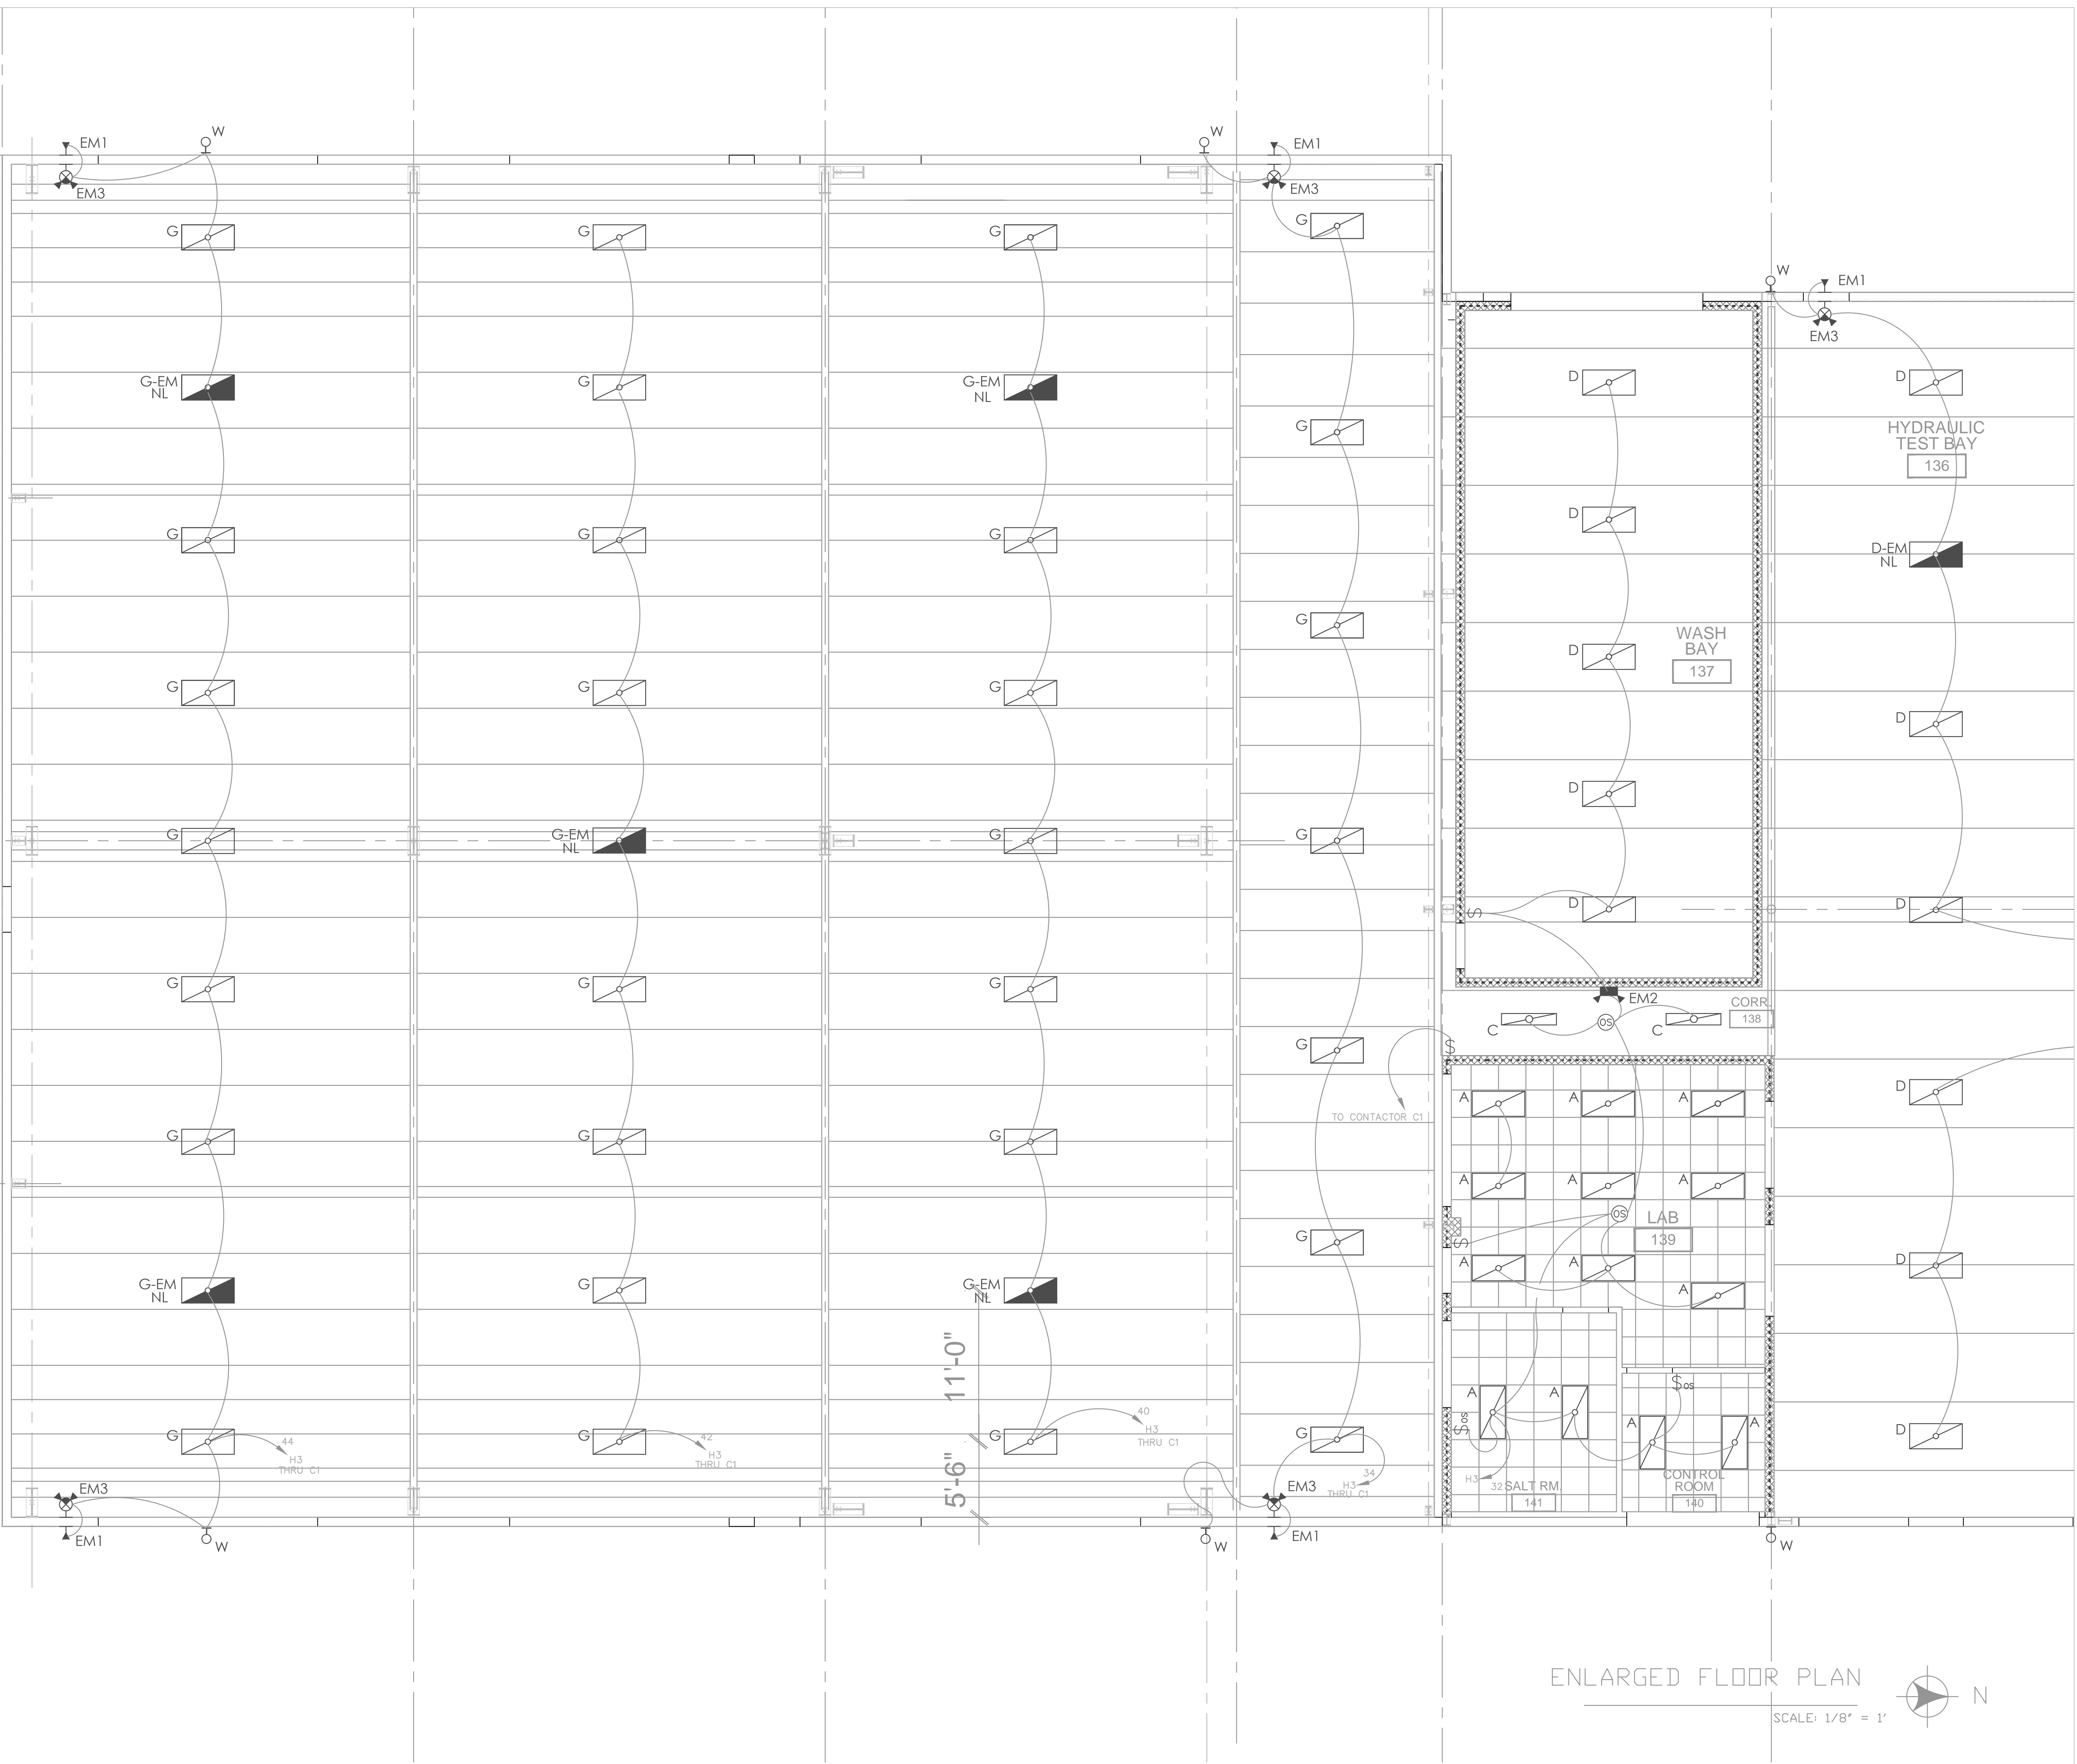

ENLARGED FLOOR PLAN

SCALE: 1/8" = 1'



RS  
ELECTRIC  
Corp

302 Messanie St.  
St. Joseph, MO 64501  
Office- 816-233-7751

NO.	DATE	REVISION	BY

ATLEC  
DESIGN ASSURANCE  
SOUTH BUILDING  
LIGHTING PLAN

ENGINEER	CHECKED BY
	M. HILMAN
JOB NO	DRAWN BY
	D. MEALS
SCALE	DATE
1/8" : 1'	6/9/2017

DWG NO  
E3.02  
SHEET NO  
9 OF 13